


6mm gate post cap
palisade security fence or similar approved
4.70
2400
7300
2m TO 4m
leveling shims and grout after
300 X 300 X 10 m.s. base plate
6-T12-150 both directions
4no.M12 holding down bolts 300 long with 50 x 50 sq.washers


ELEVATION OF SECURITY FENCE & GATE 'A' & 'B'

NOTE: GATES 'D1' & 'D2' - 8.2m WIDE CTC CONTROLLED RAIL SECURITY GATES OF SIMILAR PALLISADE TYPE TO GATES 'A' & 'B' SEE DRG 2139-2128 FOR PORT SECURITY PLAN

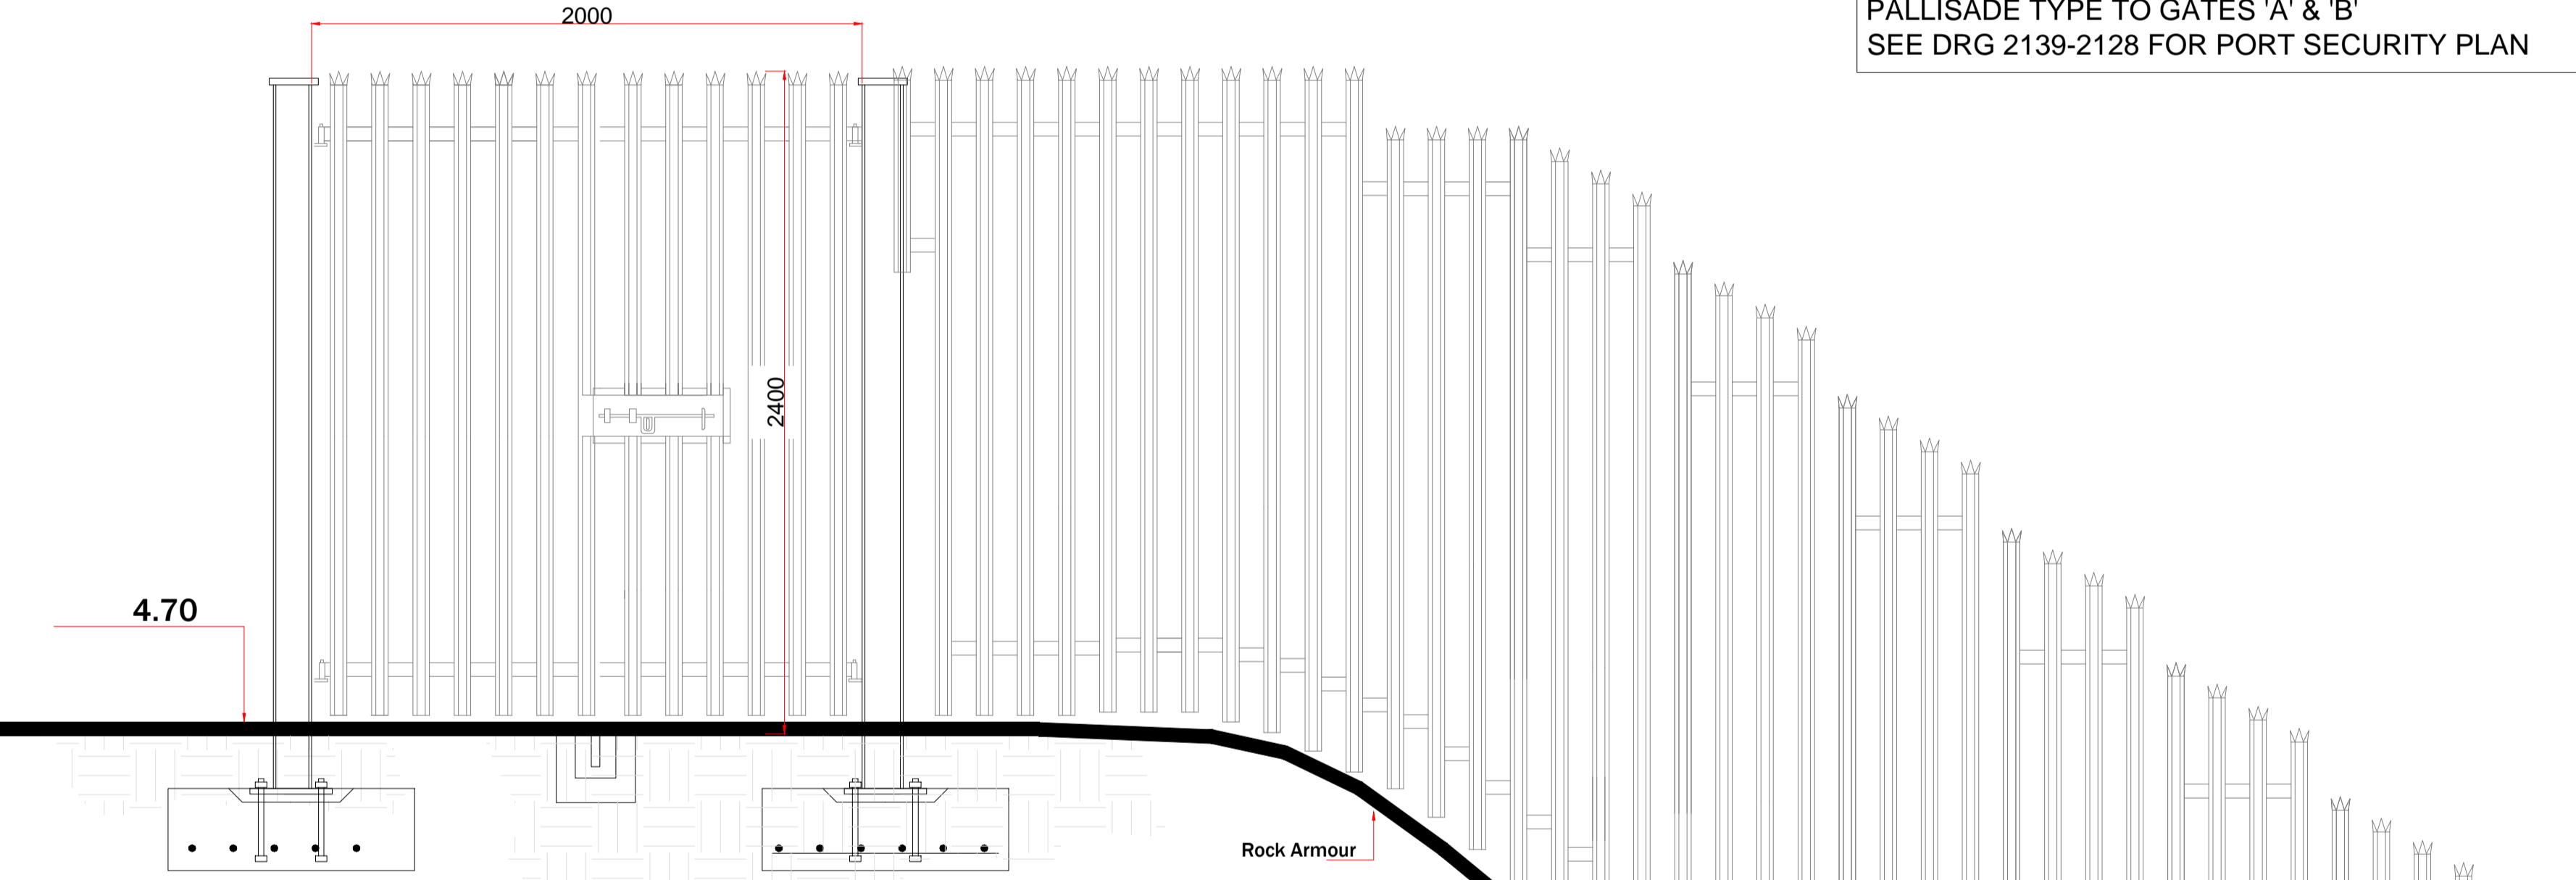

ELEVATION OF SECURITY GATE 'C'

Rock Armour

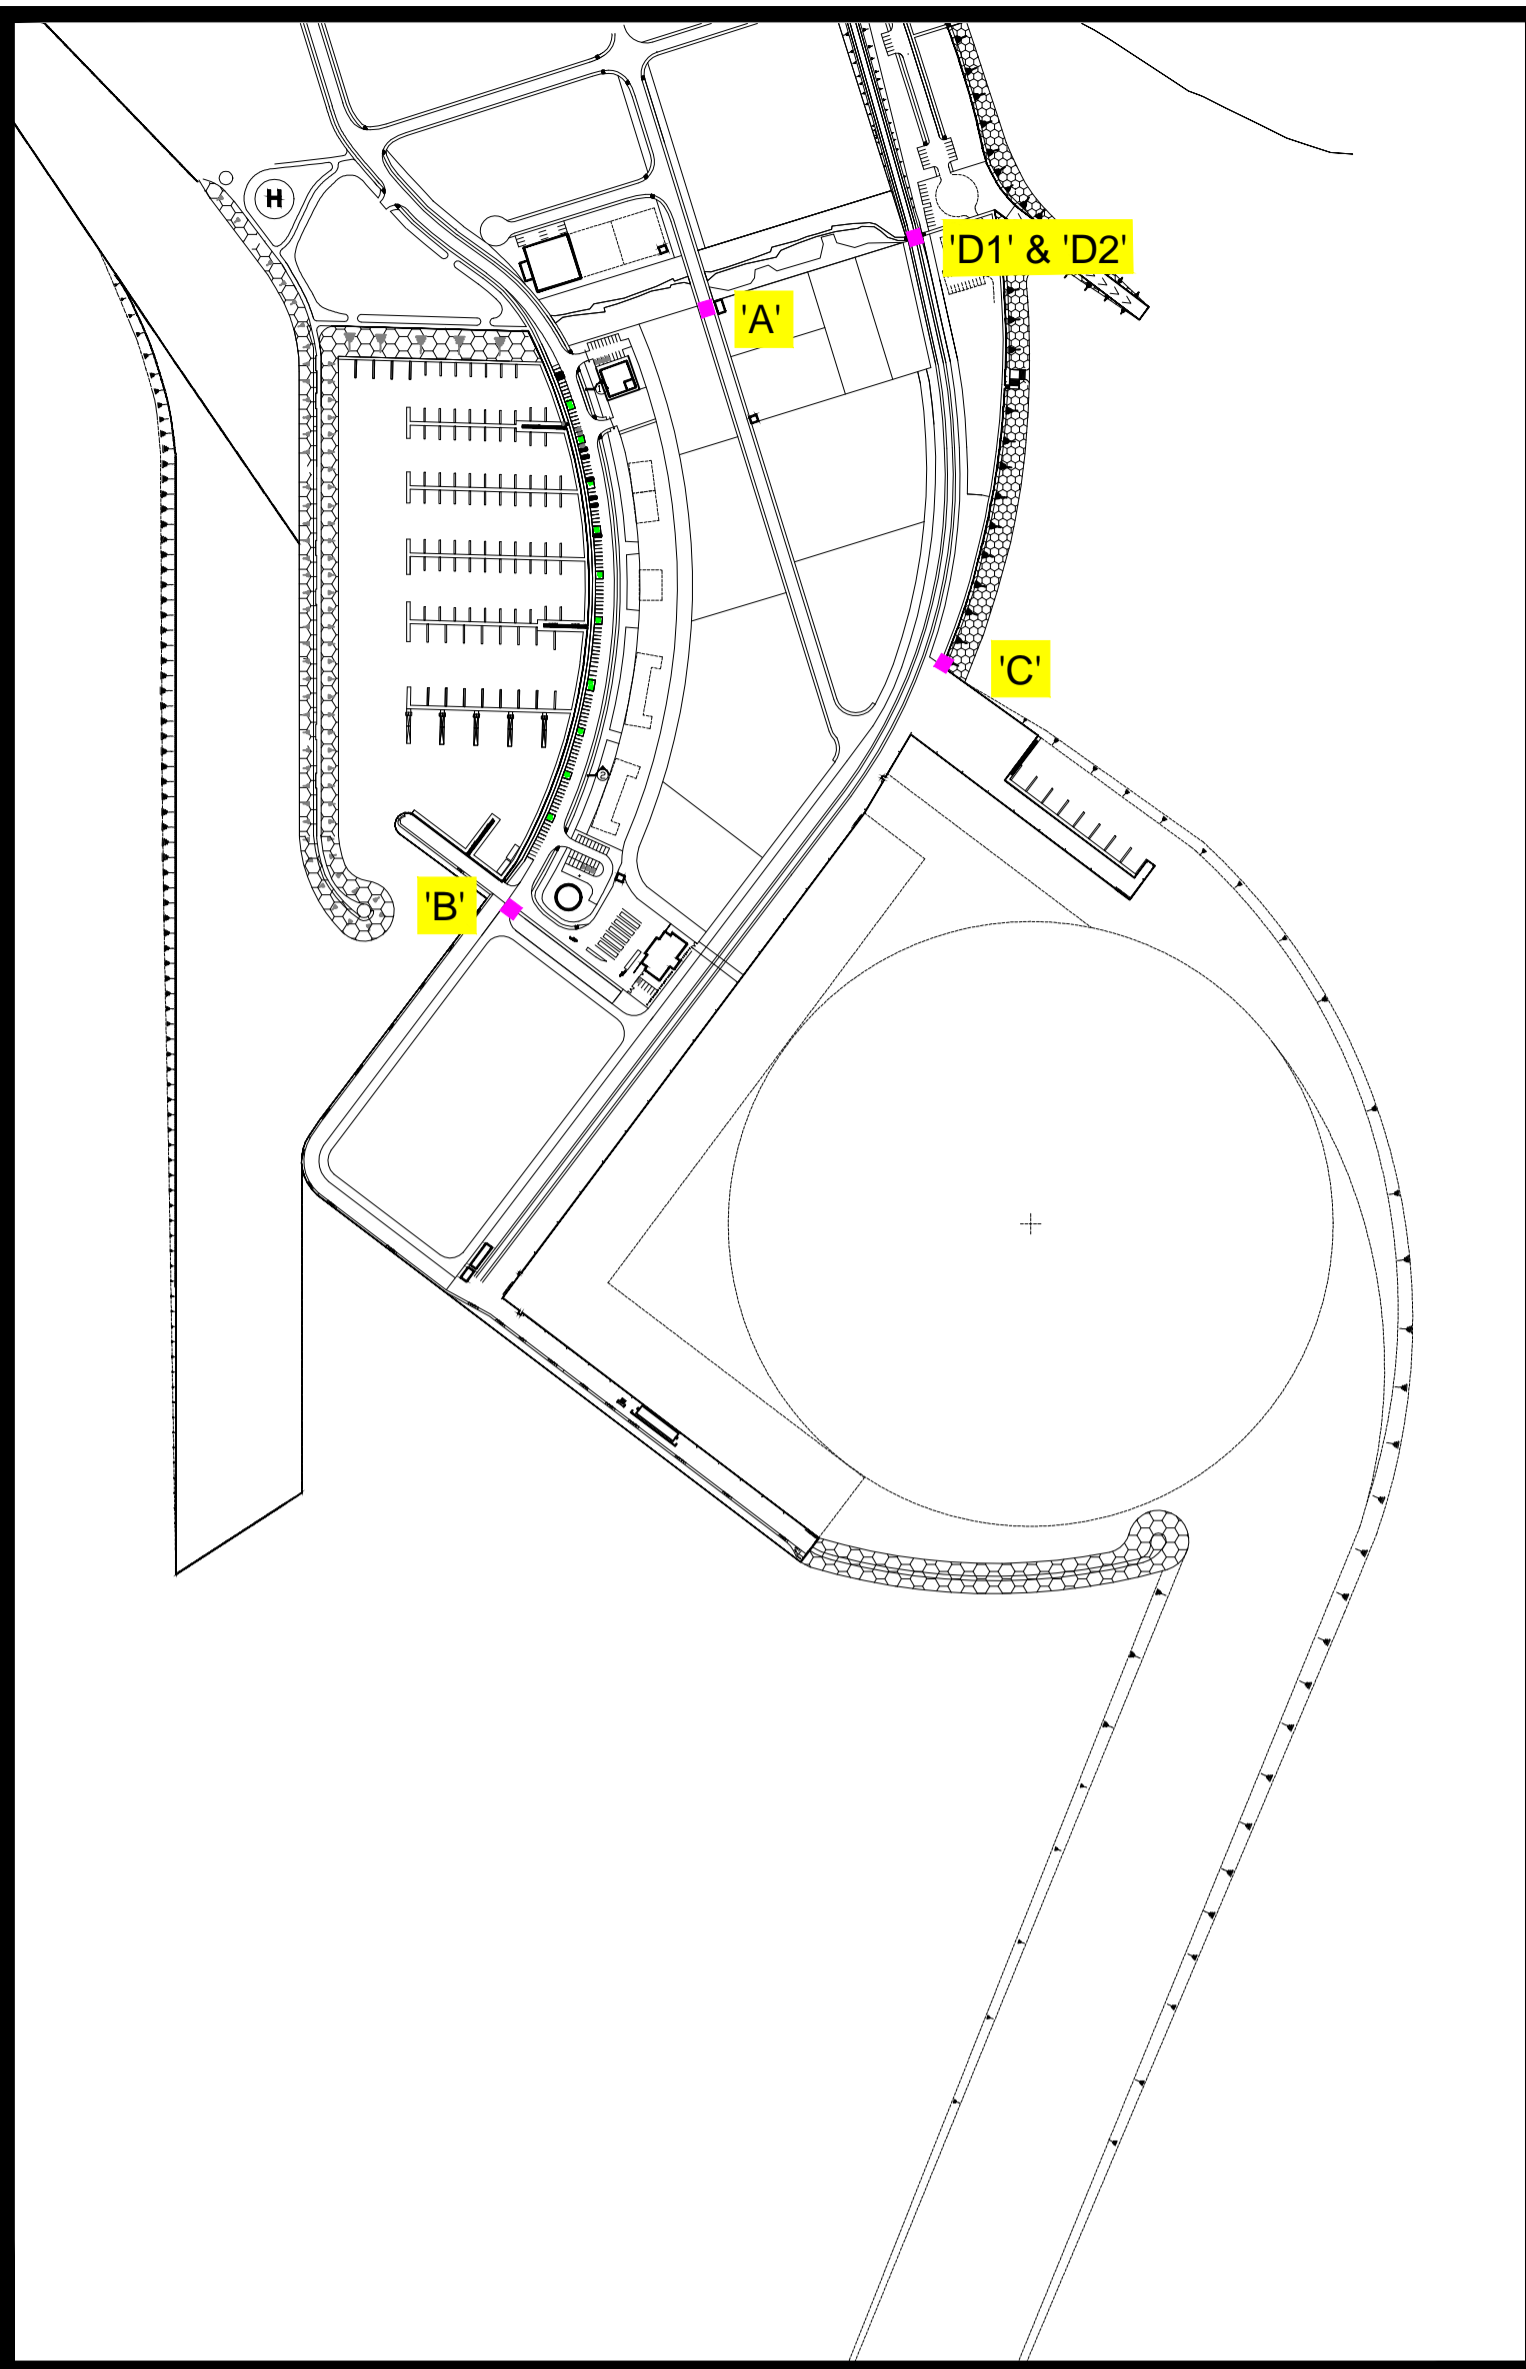

KEY PLAN

- NOTES:
1. FIGURED DIMENSIONS ONLY TO BE TAKEN FROM THIS DRAWING.
 2. ALL DRAWINGS TO BE CHECKED BY THE CONTRACTOR ON SITE
 3. ENGINEER/EMPLOYERS REPRESENTATIVE, AS APPROPRIATE, TO BE INFORMED BY THE CONTRACTOR OF ANY DISCREPANCIES BEFORE ANY WORK COMMENCES
 4. THE CONTRACTOR SHALL UNDERTAKE A THOROUGH CHECK FOR THE ACTUAL LOCATION OF ALL SERVICES/UTILITIES ABOVE AND BELOW GROUND, BEFORE ANY WORK COMMENCES
 5. ALL LEVELS SHOWN RELATE TO ORDNANCE SURVEY DATUM AT MALIN HEAD

Rev	Date	Description	By	Chkd.
A	JAN 2014	FIRST ISSUE	DW	JPK

Client:
GALWAY HARBOUR COMPANY

Project:
GALWAY HARBOUR EXTENSION

Title:
DETAIL OF SECURITY GATE & FENCE

Scale @ A1: 1/20 A3 1/40
Prepared by: DW Checked: BH Date: JAN 2014
Project Director: J.P. KELLY
Drawing Status: PLANNING & EIS

TOBIN
Patrick J. Tobin & Co. Ltd.
TOBIN Consulting Engineers,
Fairgreen House, Fairgreen Road,
Galway, Ireland.
tel: +353-(0)91-565211
fax: +353-(0)91-565398
e-mail: galway@tobin.ie
www.tobin.ie

Drawing No.: 2139-2189
Revision: A

H.A.T. 2.84

MHWN 0.9